


01
A101

PROPOSED FLOOR PLAN
SCALE: 1/8"=1'-0"

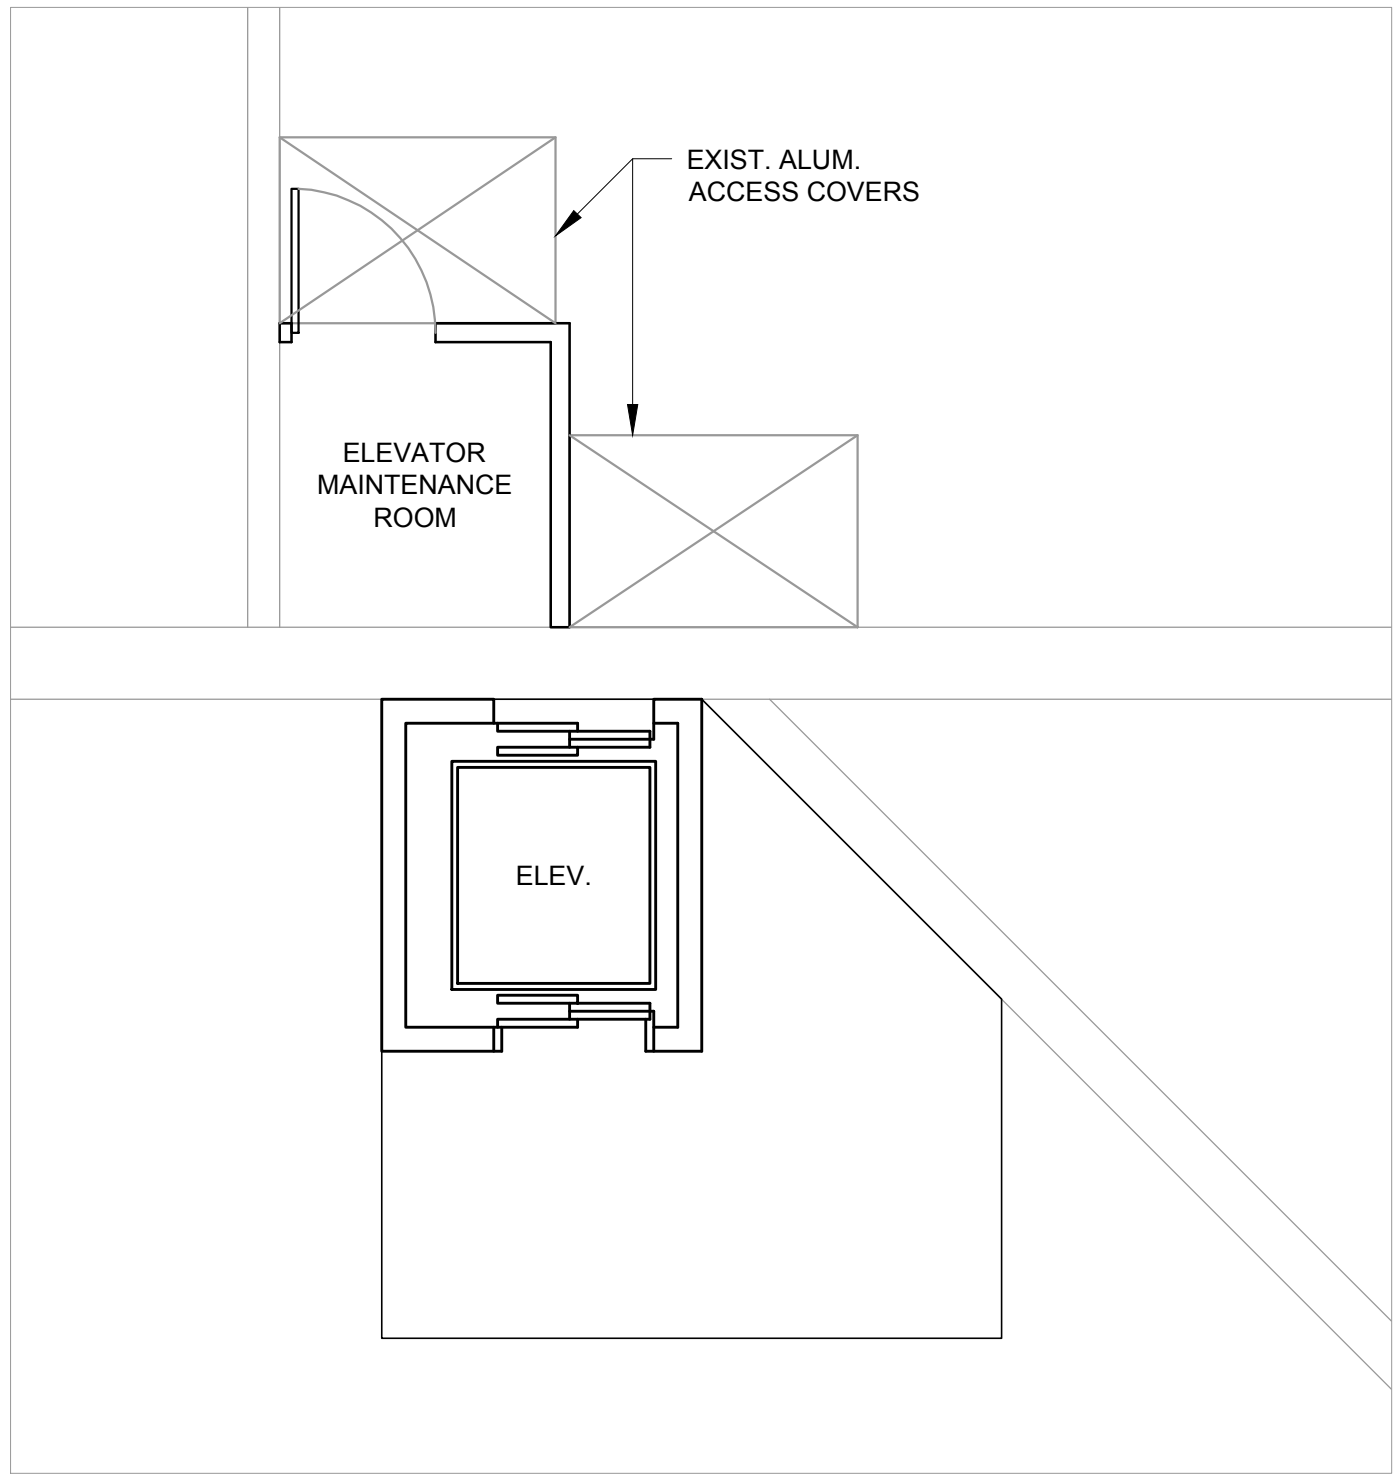

02
A101

PROPOSED LOCATION OF ELEV. MAINT. ROOM
SCALE: 1/4"=1'-0"

NOTES

SCALES

PLOTTED SIZE - 22" x 34"
SCALE: 1/8" = 1'-0"

PLOTTED SIZE - 11" x 17"
SCALE: 1/4" = 1'-0"



MIG PROJECT No.: 11110.00

A	ISSUED FOR REVIEW			2019.09.17	SP	RT	RT	RT	
NO.	REVISIONS			DATE	DRAWN	DESIGNED	CHECKED	APPROVED	

LAMBTON AREA WATER SUPPLY SYSTEM
1215 FORT ST. SARNIA, ON. N7V 1M1
OPTION 1 - MAIN FLOOR PLAN

DRAWING NUMBER

A-101

REVISION

A

X:\Projects\11110_00_LAWSS-Public-Entrance_Barrier_Fee_Upgrade_Phase\05_Drawings\02_Design\ARCH\17.09.2019\11110 LAWSS - Options.dwg sprints Sep 17, 2019 - 4:23pm